



**WATERFORD UNION HIGH SCHOOL DISTRICT
 WATERFORD UNION HIGH SCHOOL
 BUILDING ADDITION AND RENOVATIONS
 BID PACKAGE #X**

611 W. MAIN ST.
 WATERFORD, WI 53185

DESIGN DEVELOPMENT


DATE: 06.11.2025	PROJECT: WATERFORD UNION HIGH SCHOOL BUILDING ADDITION AND RENOVATIONS
DRAWN BY: ENY	CHECKED BY: WJS

OVERALL DEMOLITION PLANS


DRAWING TITLE
 OVERALL DEMOLITION PLANS

AD100

NOT FOR CONSTRUCTION

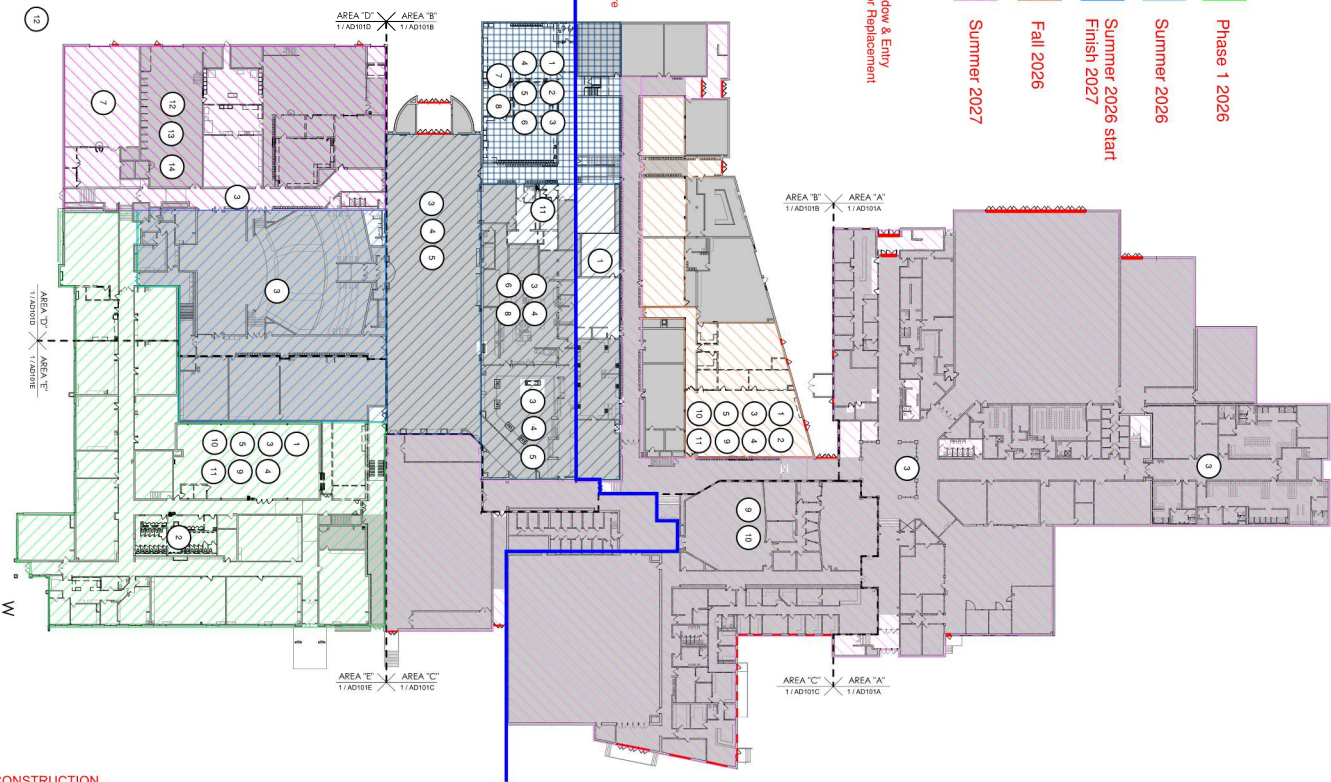

- 1. Flooring Removal and Replacement
- 2. Wall Tie Installation
- 3. Sprinkler Piping Install
- 4. ACCT ceiling tiles
- 5. ACCT ceiling Grid
- 6. Insull New Entry Roping
- 7. Office and Chair Raising
- 8. Kitchen Equipment Replacement
- 9. VAV Replacement
- 10. Mechanical Equipment Replacement
- 11. Attainment
- 12. Shop Equipment Installation
- 13. Shop Ventilation
- 14. Classroom Renovations

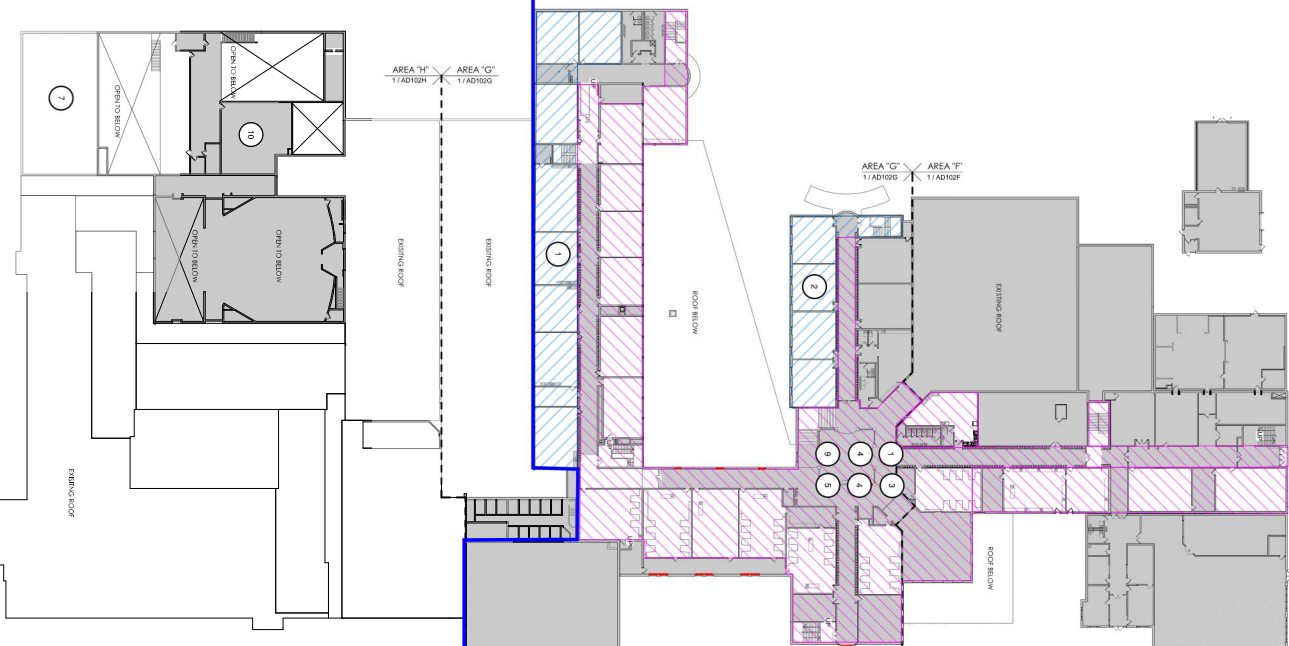

2. OVERALL SECOND FLOOR EXISTING/ DEMOLITION PLAN
 AD100 1" = 32'-0"

1. OVERALL FIRST FLOOR EXISTING/ DEMOLITION PLAN
 AD100 1" = 32'-0"