 



PROJECT NUMBER:	090650024
DRAWN BY:	MJC
CHECKED BY:	T. MOHAGEN
DATE:	4-4-19
COMPUTER DIRECTION:	MALLEN/MOHAGEN EDUCATION CENTER

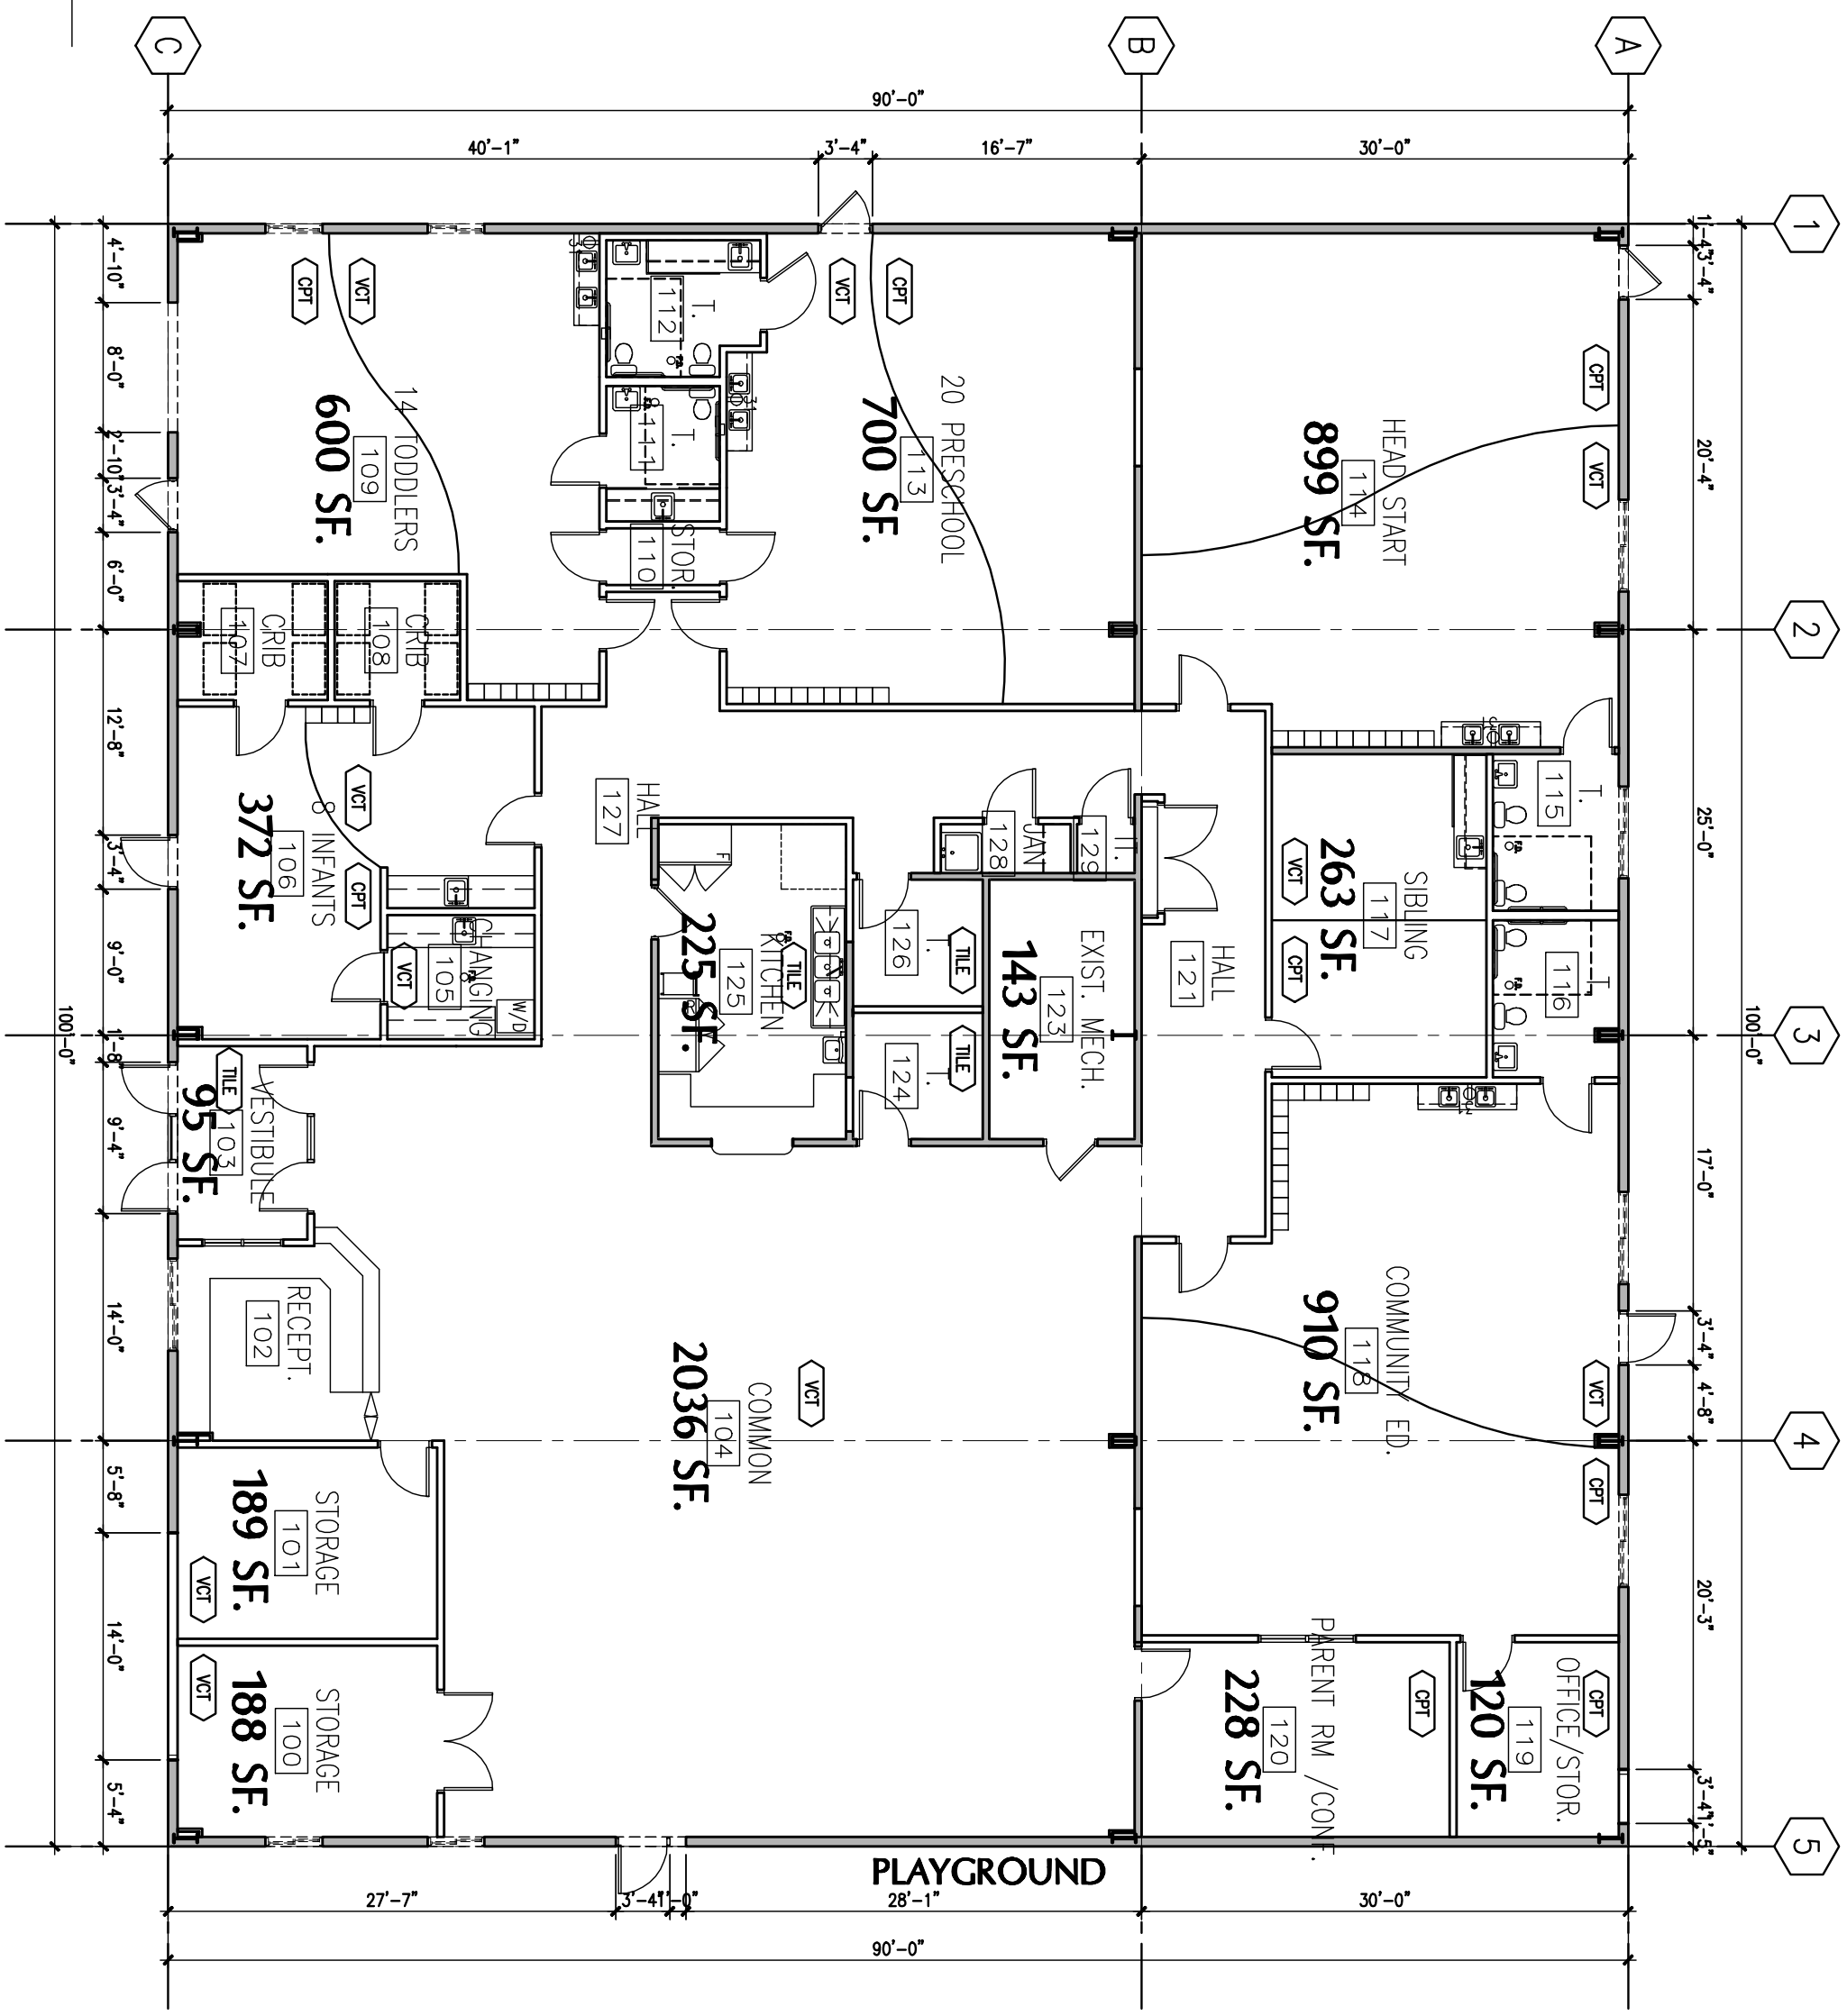

SCALE: 3/32" = 1'-0"

1 FLOOR PLAN

A2.0 3/32" = 1'-0"